


ITEM	QTY	PART NUMBER
1	3	3" ABS Closet Flange / Bride d'armoire en ABS (3 po)
2	3	3x2 ABS Bushing / Douille à expansion en ABS (3 po x 2 po)
3	5	2" ABS 45 deg / ABS 45° (2 po)
4	2	2" x 3/4" FIP ABS Bushing / Douille à expansion ABS en filetage femelle de fer (2 po x 3/4 po)
5	2	2" ABS 90 deg / BS 90° (2 po)
6	3	2" ABS Tee Wye / Raccord Té/Y en ABS (2 po)
7	4	1/2" Copper cc 90 deg / Raccord en cuivre moulé 90° (1/2 po)
8	2	3/4" MIP x 5/8" Compression / Filetage mâle de fer (3/4 po) x compression (5/8 po)
9	2	1/2" Copper cc TEE / Té en cuivre moulé (1/2 po)

**NOTE:** PIPE REQUIRED FOR PROJECT

- 2 Lengths of ABS Pipe
- 1 Length of 1/2" Type M Copper Pipe

**REMARQUE :** TUYAU REQUIS POUR LE PROJET

- 2 sections de tuyau en ABS
- 1 section de tuyau en cuivre 1/2 po de type

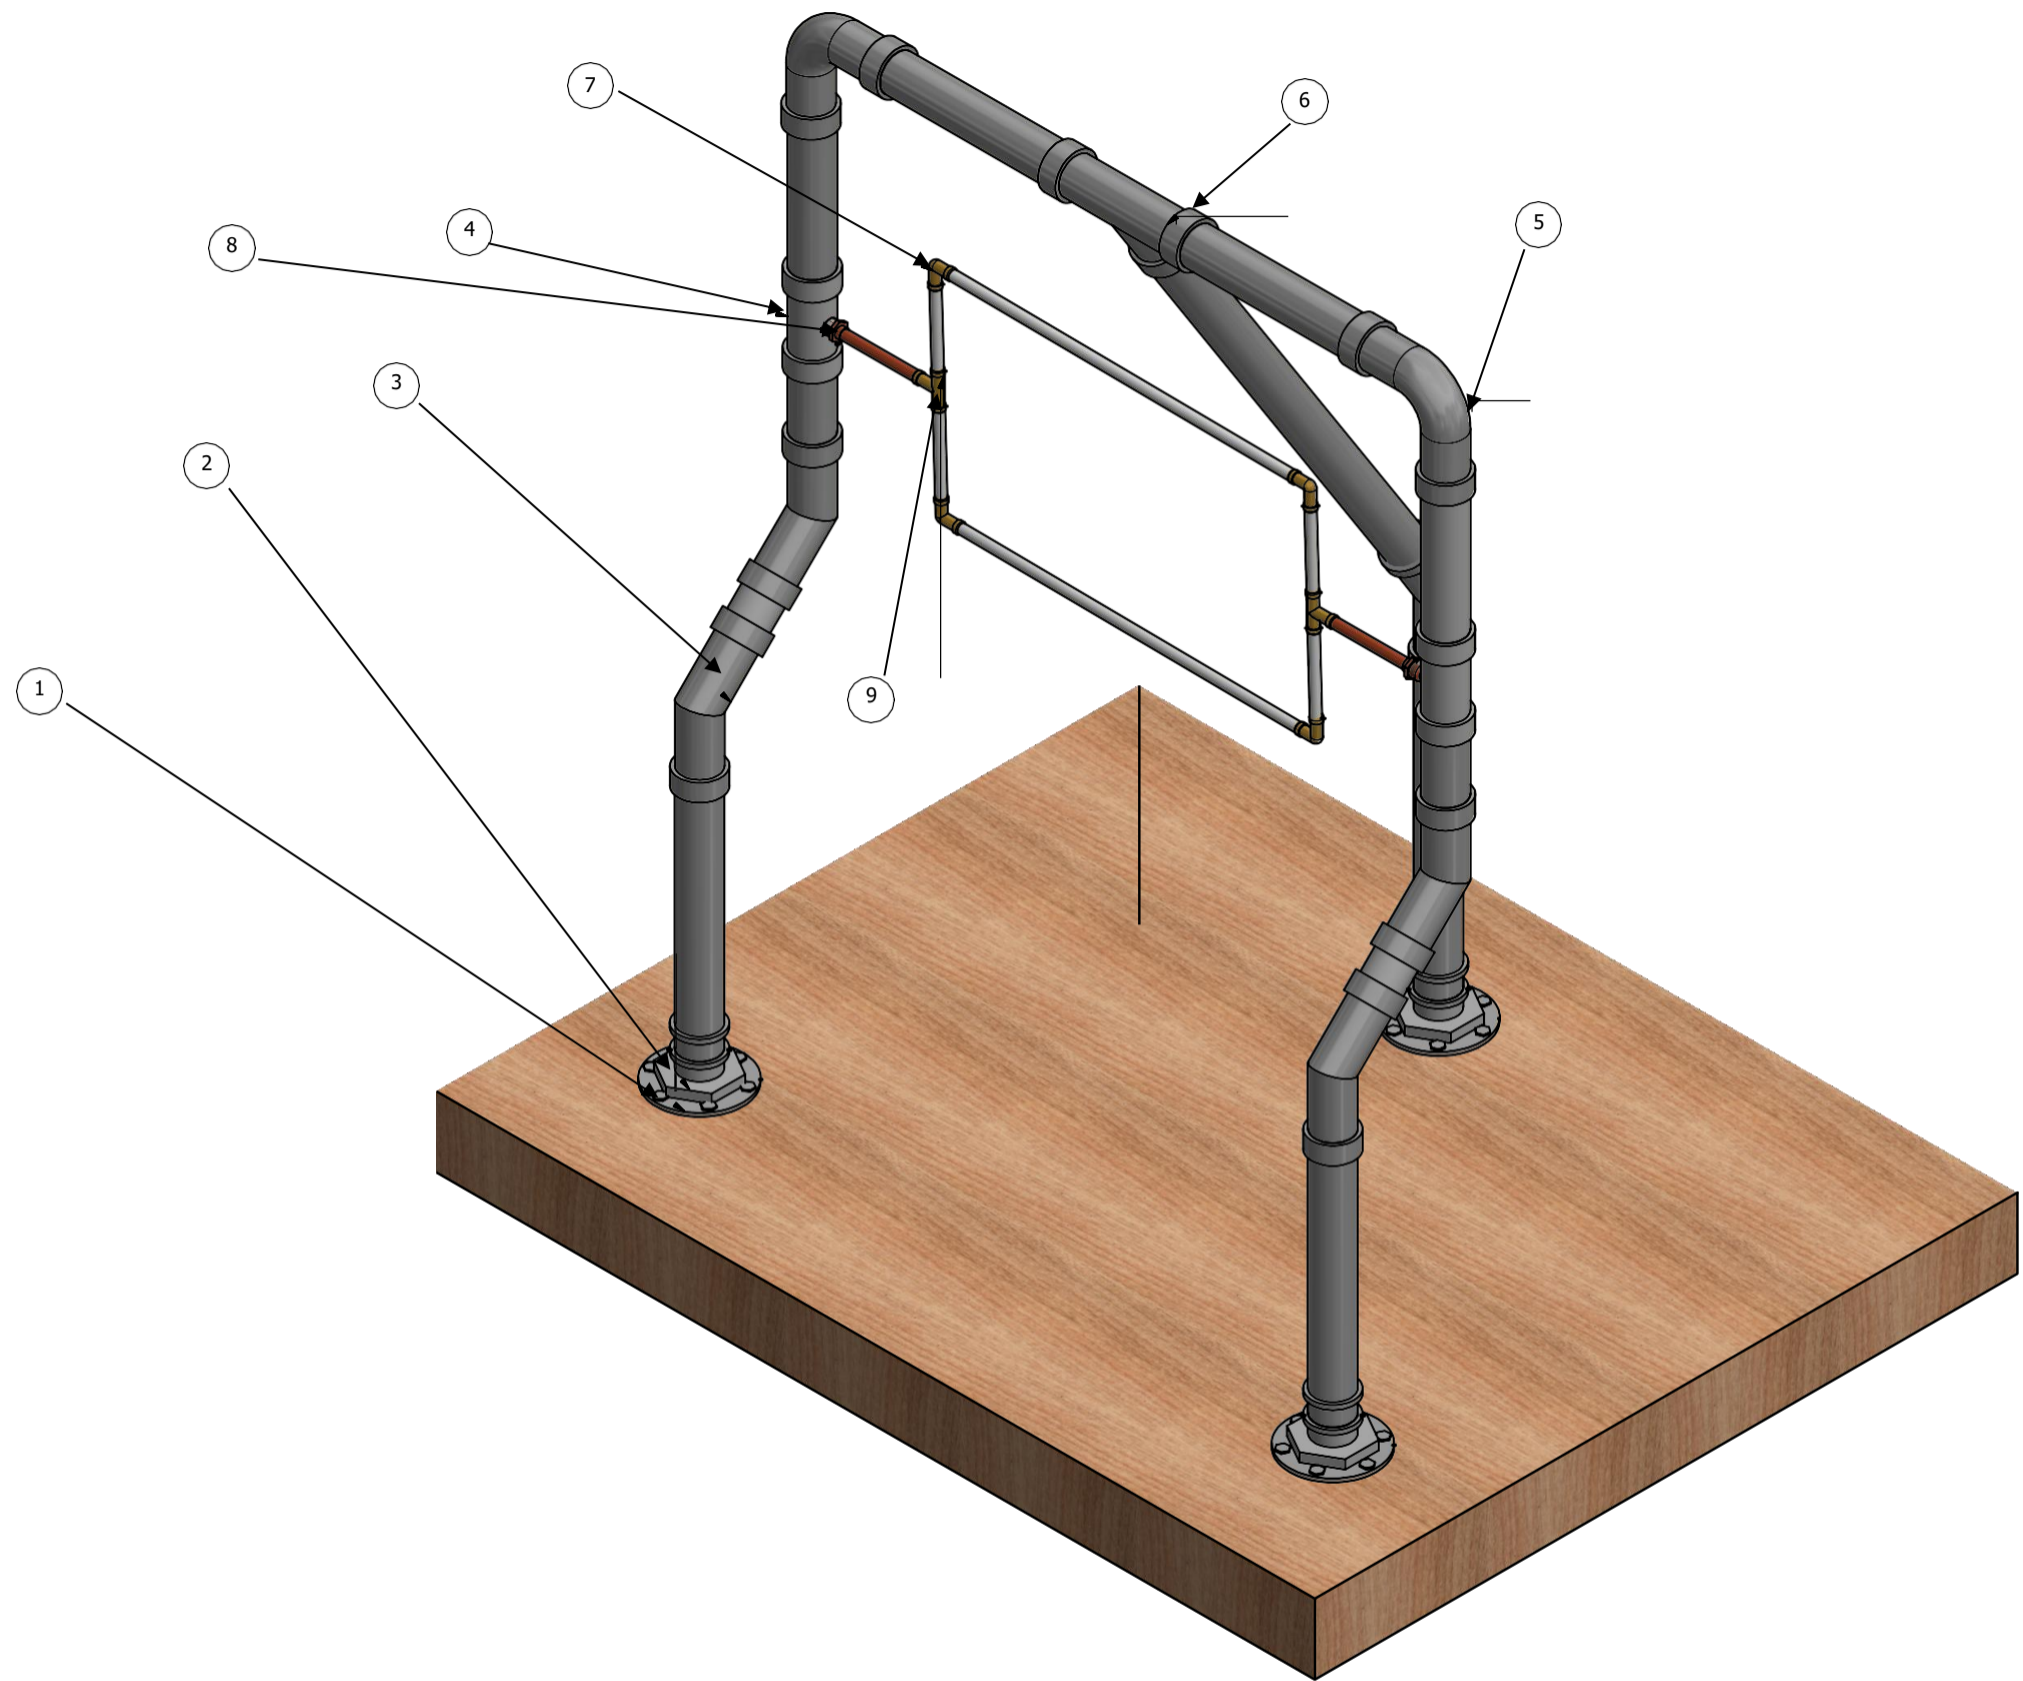

DRAWN		
TITLE		
2022 Plumbing Secondary Project/		
Project pour le concours de plomberie, palier secondaire		
SIZE	DWG NO	REV
D	Isometric View / Vue	1
SCALE	1/6" isométrique	